

Project Management Initials: Designer: KATH Checked: SYLC Approved: CWN ISO A1 594mm x 841mm

Plot File by: Jerry Wong 23-Jan-18  
 PATH: Y:\TO TO RSS\MSL\C4 Drawings\C4\_Drawing (2018\_01\_02)\A-architectural drawings -CON\60240249\_C4\_7051.dgn



**AECOM**

PROJECT  
 TUEN MUN -  
 CHEK LAP KOK LINK

CONTRACT TITLE  
 TUEN MUN - CHEK LAP KOK LINK  
 - NORTHERN CONNECTION TUNNEL  
 BUILDINGS, ELECTRICAL AND  
 MECHANICAL WORKS

CLIENT  

 路政署 DEPARTMENT  
 HIGHWAYS DEPARTMENT  
 港珠澳大橋香港工程管理有限公司  
 Hong Kong - Zhuhai - Macao Bridge  
 Hong Kong Project Management Office

CONSULTANT  
 AECOM Asia Company Ltd.  
 www.aecom.com

SUB-CONSULTANTS

**Figure 1.1**

ISSUE/REVISION

| NO. | DATE   | DESCRIPTION          | CHK. |
|-----|--------|----------------------|------|
| A   | JAN.18 | TENDER ADDENDUM NO.1 | SYLC |
| -   | DEC.17 | TENDER DRAWING       | SYLC |

STATUS

SCALE  
 A1 1:40000  
 DIMENSION UNIT  
 MILLIMETRES

KEY PLAN

PROJECT NO. 60240249  
 CONTRACT NO. HY/2017/10

SHEET TITLE  
 OVERALL SITE PLAN

SHEET NUMBER  
 60240249/C4/7051A

Ref File by: jerrywang 23-Jan-18  
 PATH: Y:\1010\SS\SI\C4 Drawings\C4\_Drawing (2018\_01\_02)\Architectural drawings - DSN\60240249\_C4\_7061.dgn  
 Project Management Initials: Designer: KATH Checked: SYLC Approved: CWN ISO A1 594mm x 841mm  
 01/11/18



**AECOM**

PROJECT  
TUEN MUN - CHEK LAP KOK LINK

CONTRACT TITLE  
TUEN MUN - CHEK LAP KOK LINK - NORTHERN CONNECTION TUNNEL BUILDINGS, ELECTRICAL AND MECHANICAL WORKS

CLIENT  
路政署 HIGHWAYS DEPARTMENT  
港務局 大橋香港工程管理有限公司  
Hong Kong - Zhuhai - Macao Bridge  
Hong Kong Project Management Office

CONSULTANT  
AECOM Asia Company Ltd.  
www.aecom.com

SUB-CONSULTANTS  
S.P.L. GROUP

## Figure 1.2a

ISSUE/REVISION

| NO. | DATE   | DESCRIPTION          | CHK. |
|-----|--------|----------------------|------|
| A   | JAN.18 | TENDER ADDENDUM NO.1 | SYLC |
| -   | DEC.17 | TENDER DRAWING       | SYLC |

STATUS

SCALE  
A1 1:2500

DIMENSION UNIT  
MILLIMETRES

KEY PLAN



PROJECT NO.  
60240249

CONTRACT NO.  
HY/2017/10

SHEET TITLE  
ZONING PLAN (SHEET 1)

SHEET NUMBER  
60240249/C4/7061A

This drawing has been prepared for the use of AECOM's client. It may not be used, modified, reproduced or distributed without the prior written consent of AECOM. AECOM accepts no responsibility for any party that uses or relies on this drawing without AECOM's express written consent. Do not scale this document. All measurements must be obtained from the master drawings.

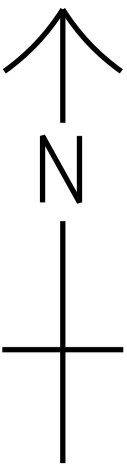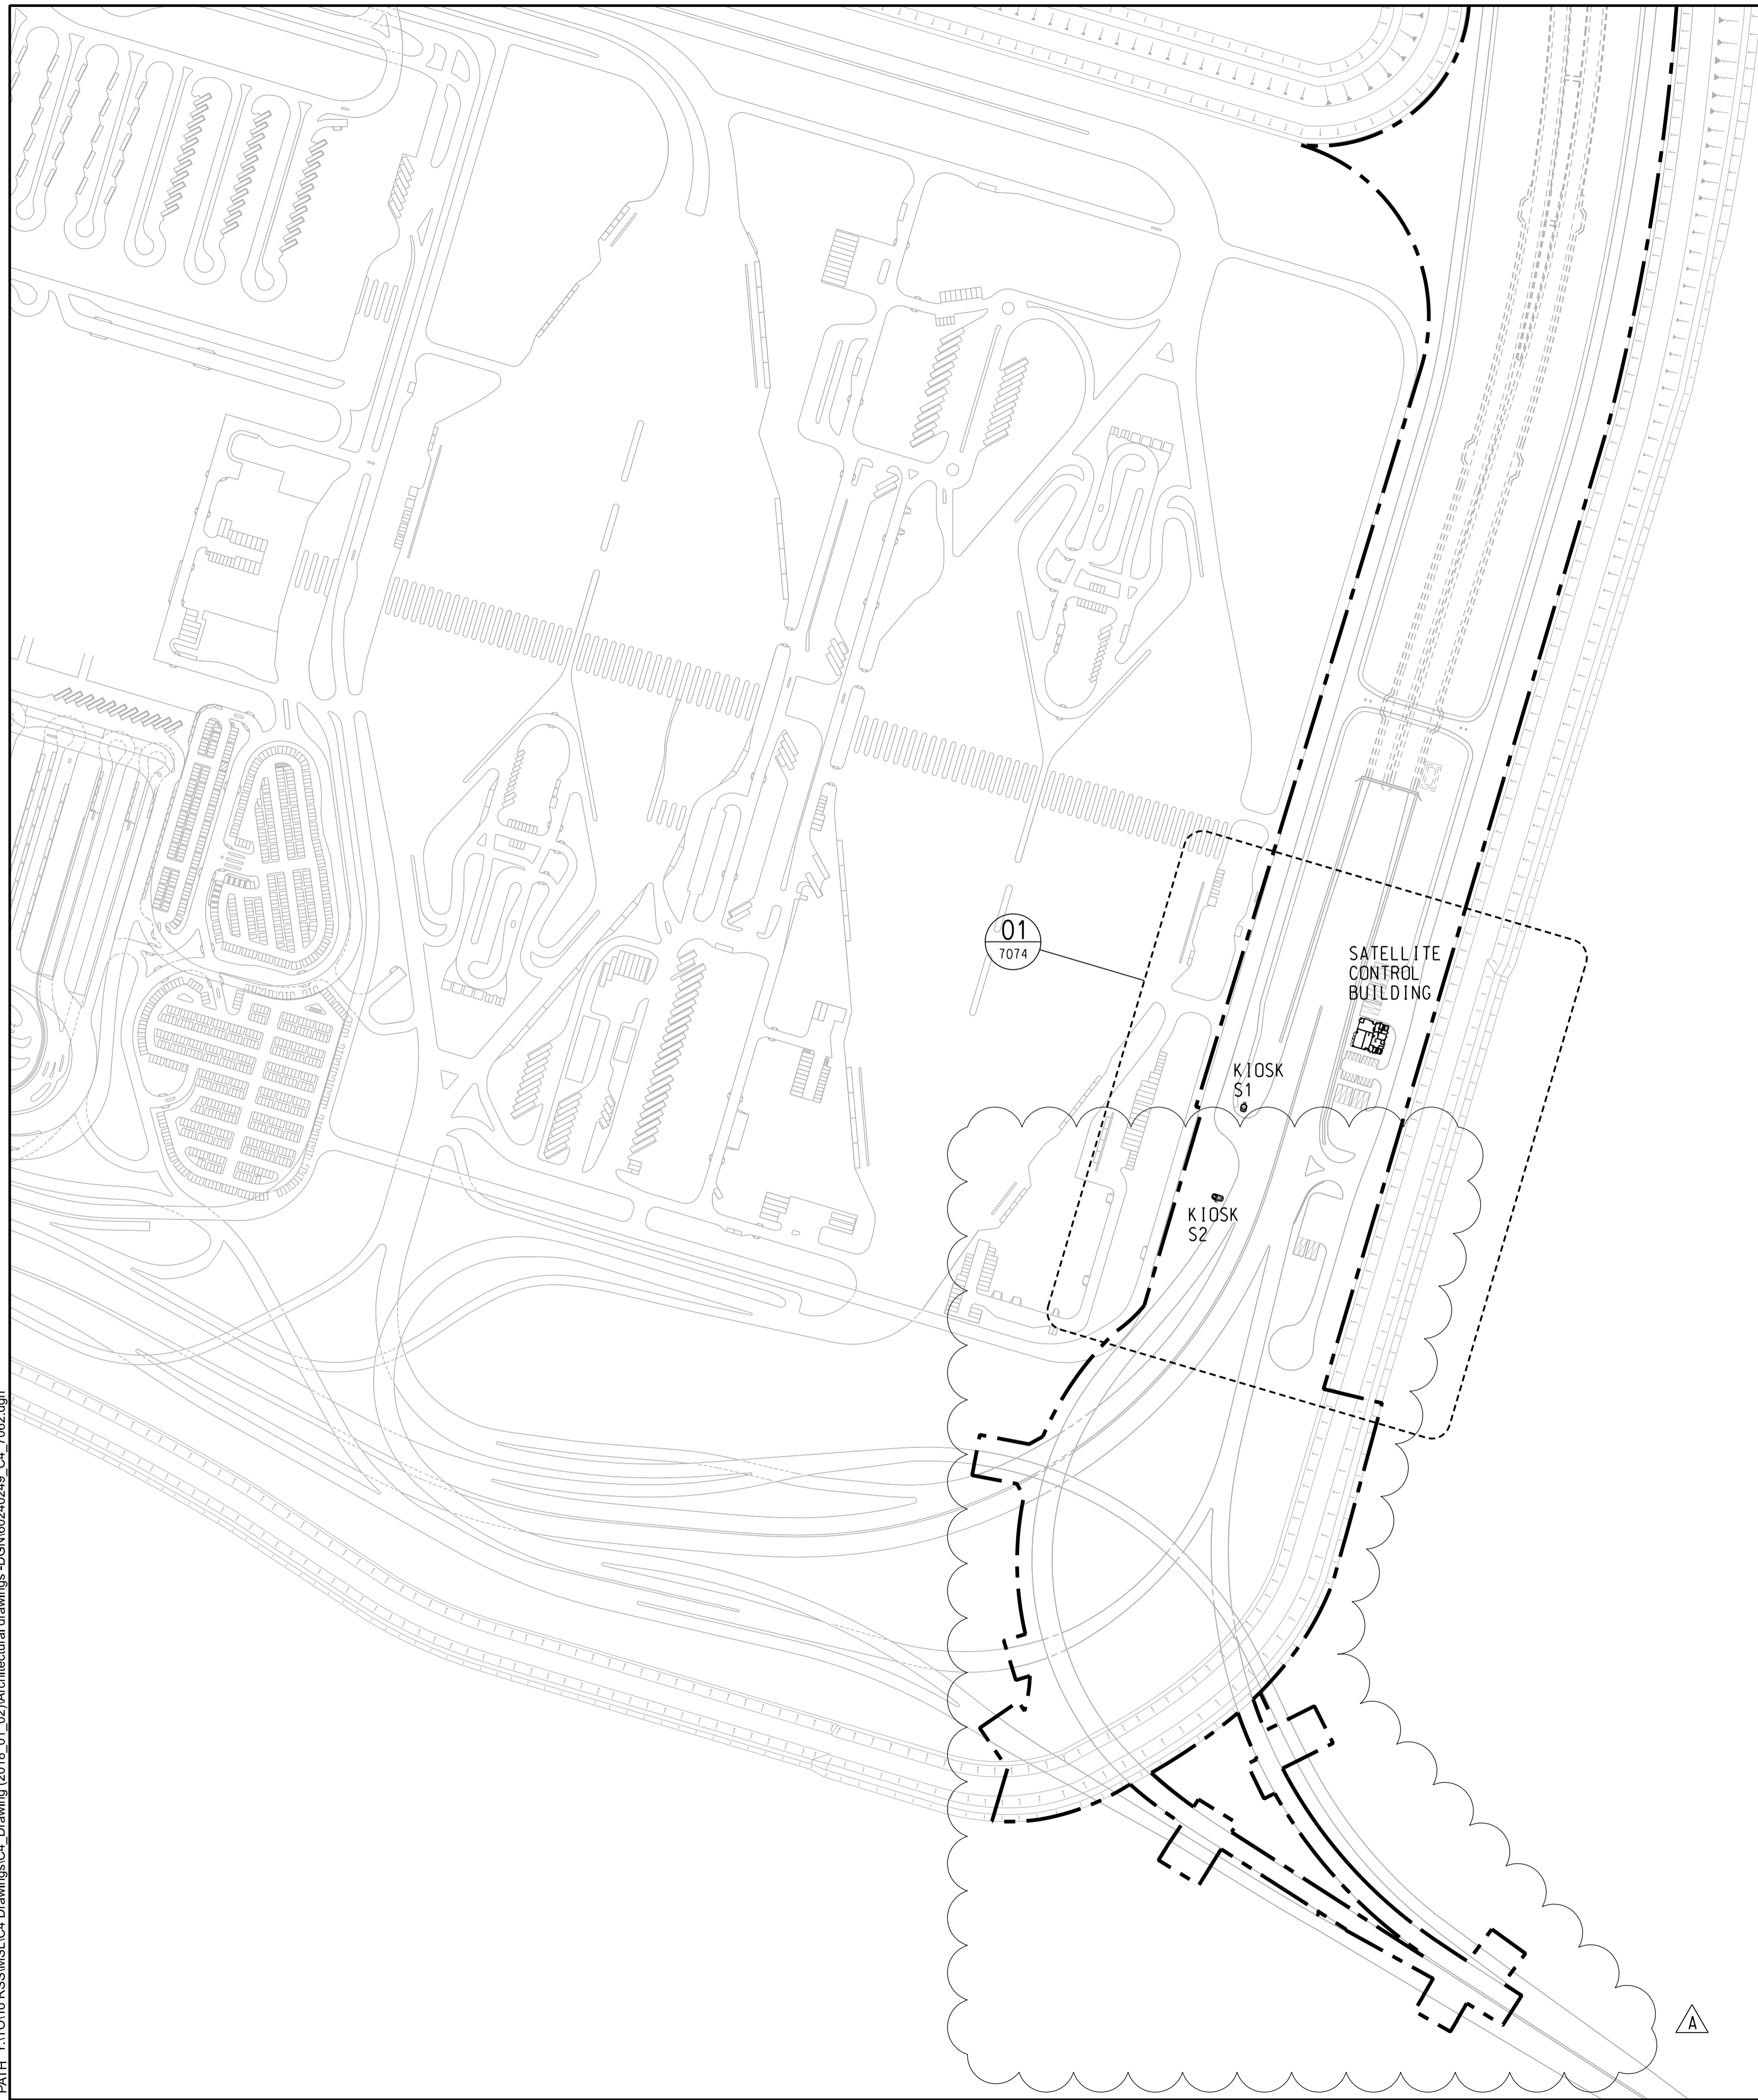

**AECOM**

PROJECT  
 項目

**TUEN MUN -  
 CHEK LAP KOK LINK**

CONTRACT TITLE  
 TUEN MUN - CHEK LAP KOK LINK  
 - NORTHERN CONNECTION TUNNEL  
 BUILDINGS, ELECTRICAL AND  
 MECHANICAL WORKS

CLIENT  
 業主



CONSULTANT  
 工程師公司

AECOM Asia Company Ltd.  
 www.aecom.com

SUB-CONSULTANTS  
 分判工程師公司

**Figure 1.2b**

ISSUE/REVISION  
 修訂

| I/R<br>修訂 | DATE<br>日期 | DESCRIPTION<br>修訂描述  | CHK.<br>核對 |
|-----------|------------|----------------------|------------|
| A         | JAN.18     | TENDER ADDENDUM NO.1 | SYLC       |
| -         | DEC.17     | TENDER DRAWING       | SYLC       |

STATUS  
 階段

SCALE  
 比例

A1 1 : 2500

DIMENSION UNIT  
 尺寸單位

MILLIMETRES

KEY PLAN  
 索引圖

PROJECT NO.  
 項目編號

60240249

CONTRACT NO.  
 合約編號

HY/2017/10

SHEET TITLE  
 圖紙名稱

ZONING PLAN  
 (SHEET 2)


SHEET NUMBER  
 圖紙編號

60240249/C4/7062A

This drawing has been prepared for the use of AECOM's client. It may not be used, modified, reproduced or relied upon by third parties, except as agreed by AECOM or as required by law. AECOM accepts no responsibility, and denies any liability whatsoever, for any party that uses or relies on this drawing without AECOM's express written consent. Do not scale this document. All measurements must be obtained from the stated dimensions.

Project Management Initials: Designer: KATH Checked: SYLC Approved: CWN  
 16/1/18  
 CWS

Pld File by: jerrywong  
 PATH: \\TOTO10-RSS\MSL\C4 Drawings\C4\_Drawing (2018\_01\_02)\Architectural Drawings-DGN\60240249\_C4\_7063.dgn

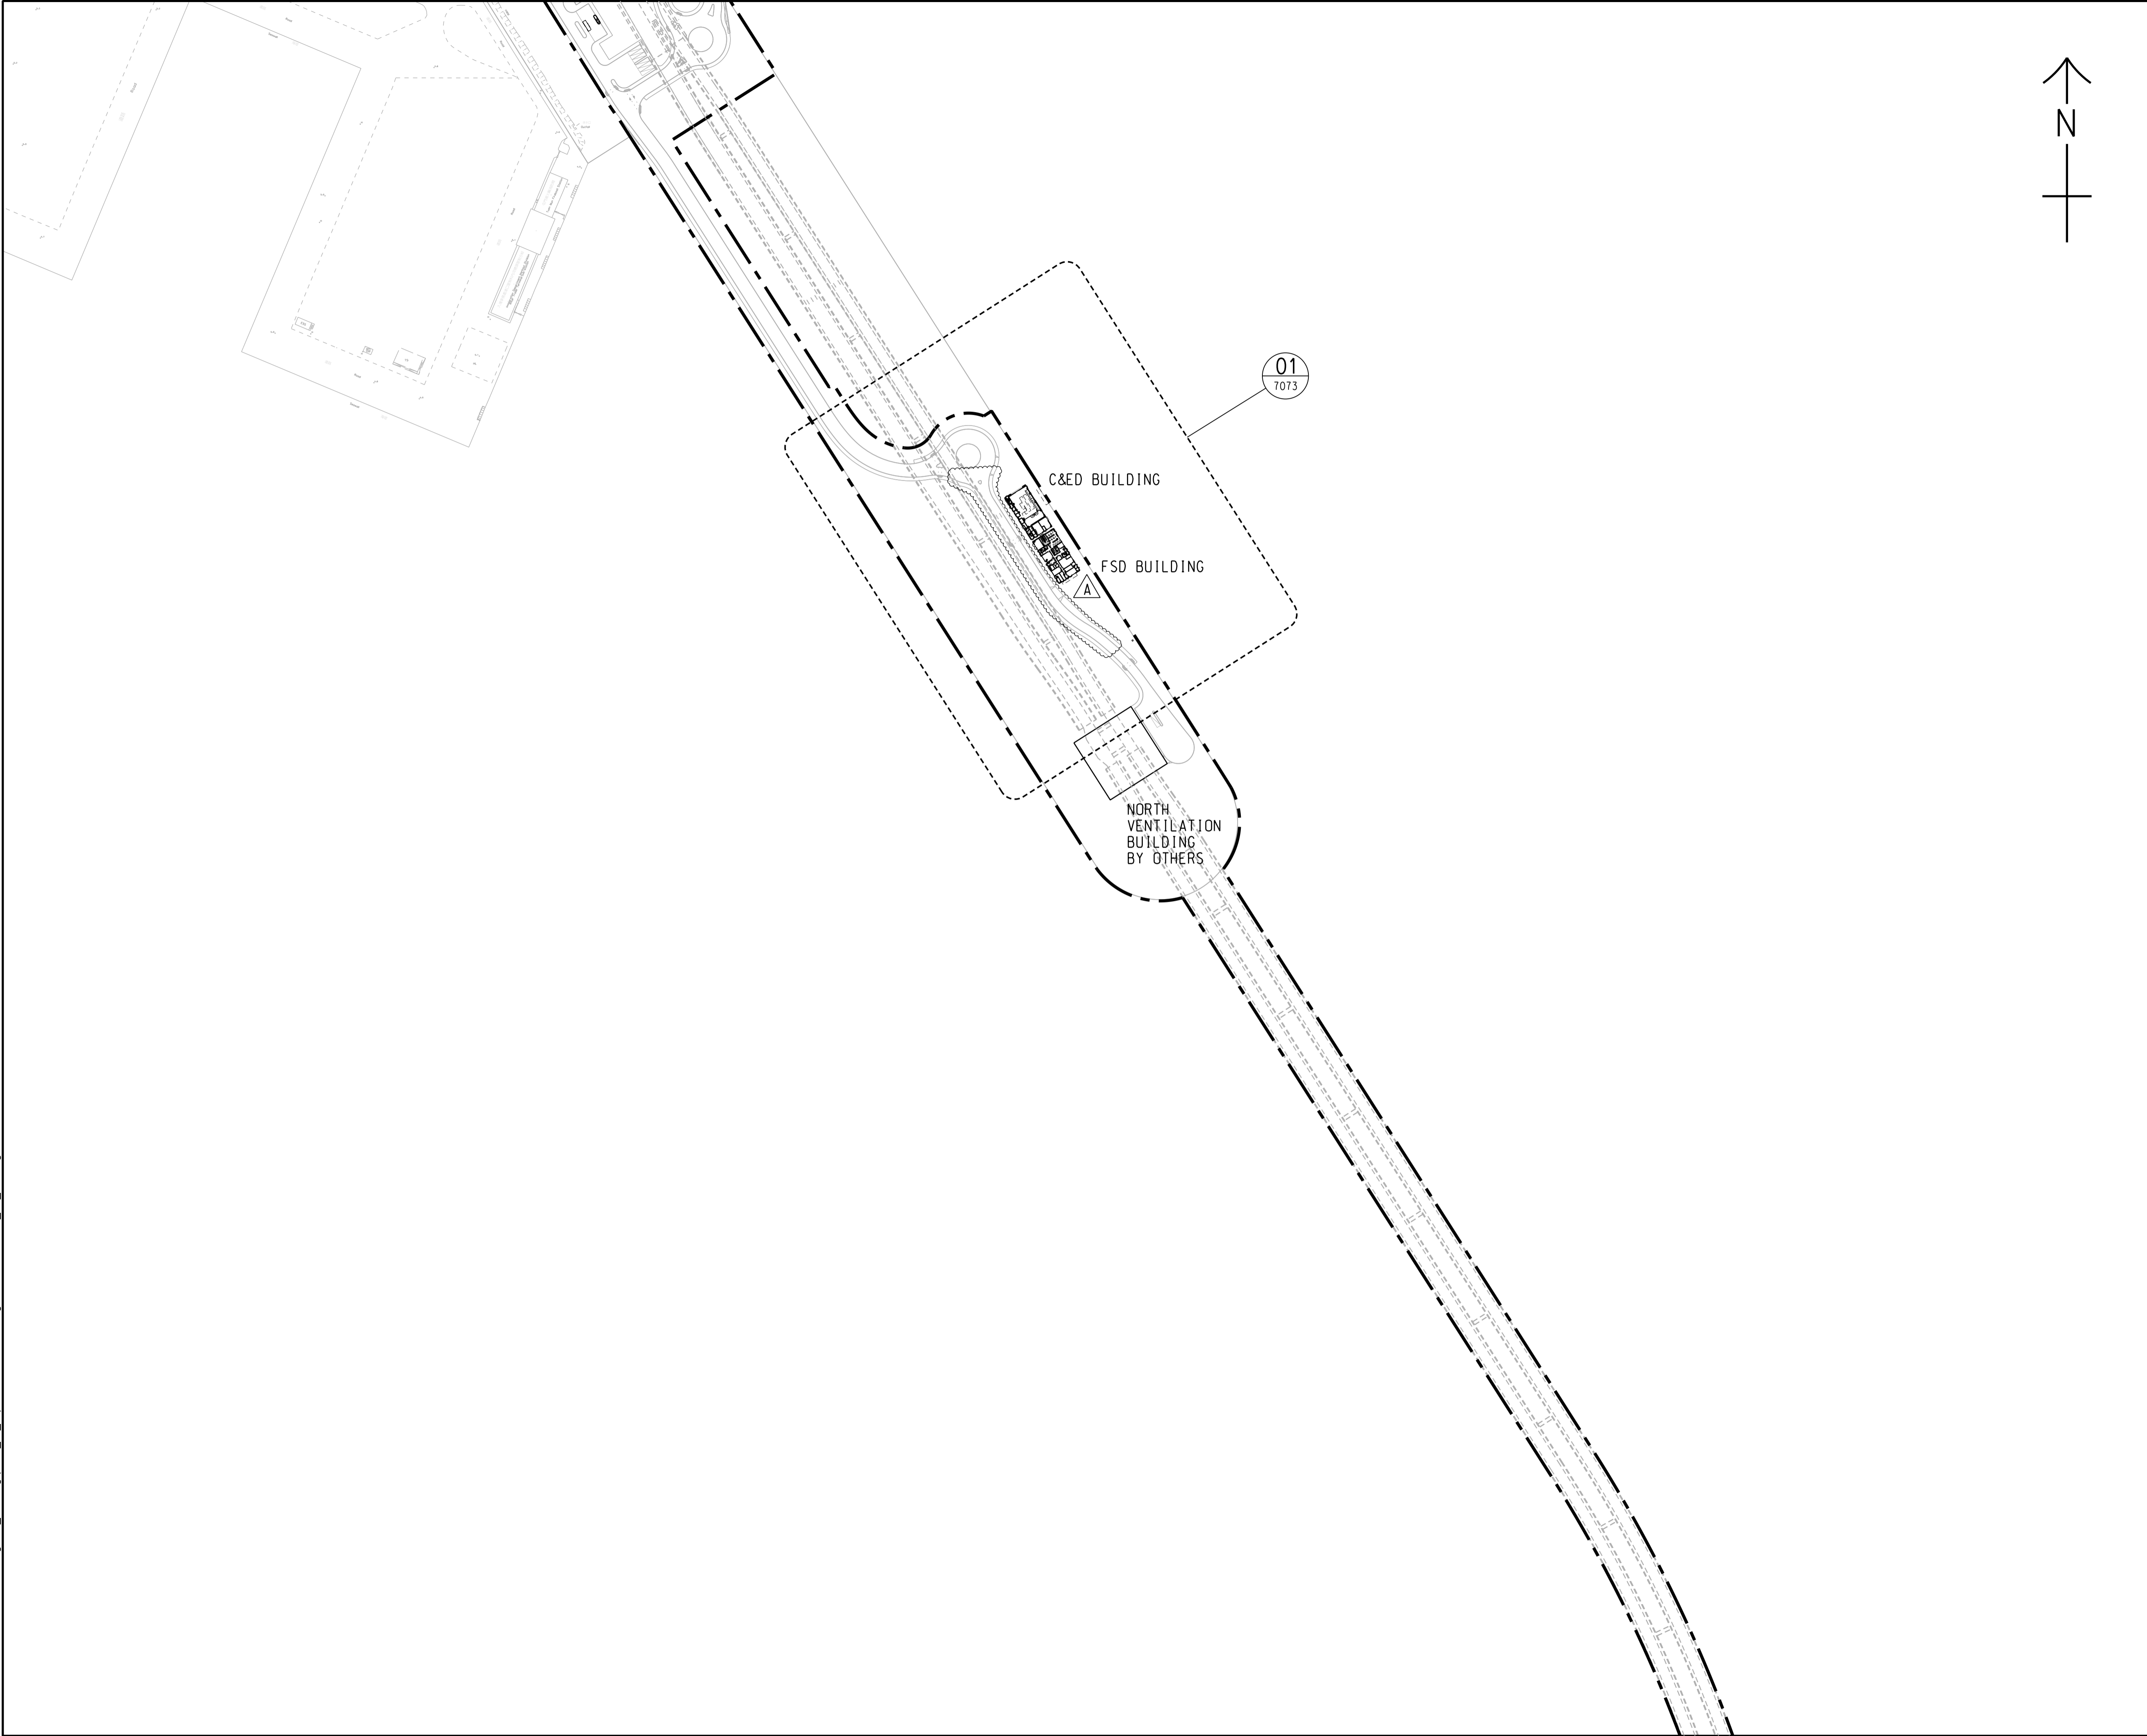

This drawing has been prepared for the use of AECOM's client. It may not be used, modified, reproduced or relied upon by third parties, except as agreed by AECOM or as required by law. AECOM accepts no responsibility, and denies any liability whatsoever, to any party that uses or relies on this drawing without AECOM's express written consent. Do not scale this document. All measurements must be obtained from the stated dimensions.



**PROJECT**  
 項目  
**TUEN MUN - CHEK LAP KOK LINK**

**CONTRACT TITLE**  
 合約標題  
 TUEN MUN - CHEK LAP KOK LINK - NORTHERN CONNECTION TUNNEL BUILDINGS, ELECTRICAL AND MECHANICAL WORKS

**CLIENT**  
 業主  
 **路政署 HIGHWAYS DEPARTMENT**  
 港珠澳大橋香港工程管理處  
 Hong Kong - Zhuhai - Macao Bridge  
 Hong Kong Project Management Office

**CONSULTANT**  
 顧問公司  
 AECOM Asia Company Ltd.  
 www.aecom.com

**SUB-CONSULTANTS**  
 分判工程師公司

**Figure 1.2c**

**ISSUE/REVISION**  
 修訂

| I/R | DATE   | DESCRIPTION          | CHK. |
|-----|--------|----------------------|------|
| 修訂  | 日期     | 內容摘要                 | 核校   |
| A   | JAN.18 | TENDER ADDENDUM NO.1 | SYLC |
| -   | DEC.17 | TENDER DRAWING       | SYLC |

**STATUS**  
 階段

**SCALE**  
 比例  
 A1 1 : 2500

**DIMENSION UNIT**  
 尺寸單位  
 MILLIMETRES

**KEY PLAN**  
 索引圖

**PROJECT NO.**  
 項目編號  
 60240249

**CONTRACT NO.**  
 合約編號  
 HY/2017/10

**SHEET TITLE**  
 圖紙名稱  
 ZONING PLAN (SHEET 3)

**SHEET NUMBER**  
 圖紙編號  
 60240249/C4/7063A